

OF BUILDINGS
CAL)

BRICK PAVING

IPE

LINGS

TRACK

TRACK

LEGEND

- 80 mm Lateral Drains
- 150 mm Twin wall main drains
- 225 mm Twin wall main drains
- 300 mm Twin wall main drains
- Slit drains
- Slit Chambers
- Floodlights
- Floodlight Ducting

Draft for Information

THIS DRAWING, DESIGN AND INFORMATION IS
SUBJECT TO COPYRIGHT OF THE SPORTS TURF
RESEARCH INSTITUTE (STRI).

IT MUST NOT BE REPRODUCED, COPIED OR USED
IN ANY WAY WITHOUT WRITTEN PERMISSION
OF THE COMPANY.

IT IS THE CONTRACTORS RESPONSIBILITY TO
ASCERTAIN THE LOCATION OF ALL SERVICES
PRIOR TO COMMENCEMENT OF WORK.

SETTING OUT SHALL BE THE RESPONSIBILITY
OF THE CONTRACTOR, ANY DISCREPANCIES
SHALL BE REPORTED AND CLARIFIED AT
THE EARLIEST OPPORTUNITY.

NOTES



STRI
St Ives Estate
Bingley
West Yorkshire
BD16 1AU
Tel: 01274 565131
Fax: 01274 561891
email: cad@stri.co.uk

CLIENT

Limerick University

PROJECT

Development of Natural Turf Pitches

DRAWING TITLE


Proposed Drainage Layout
Revision - 29.01.10

DRAWN BY MP
CHECKED RH
DATE 29/01/10
SCALE 1:500
DRAWING NO DE101167 Drainage Layout Draft


REV	DETAILS	DR	CH	AP	DATE

*** Unchecked added file names and paths ***

PROPERTY OF AST COMPUTERS

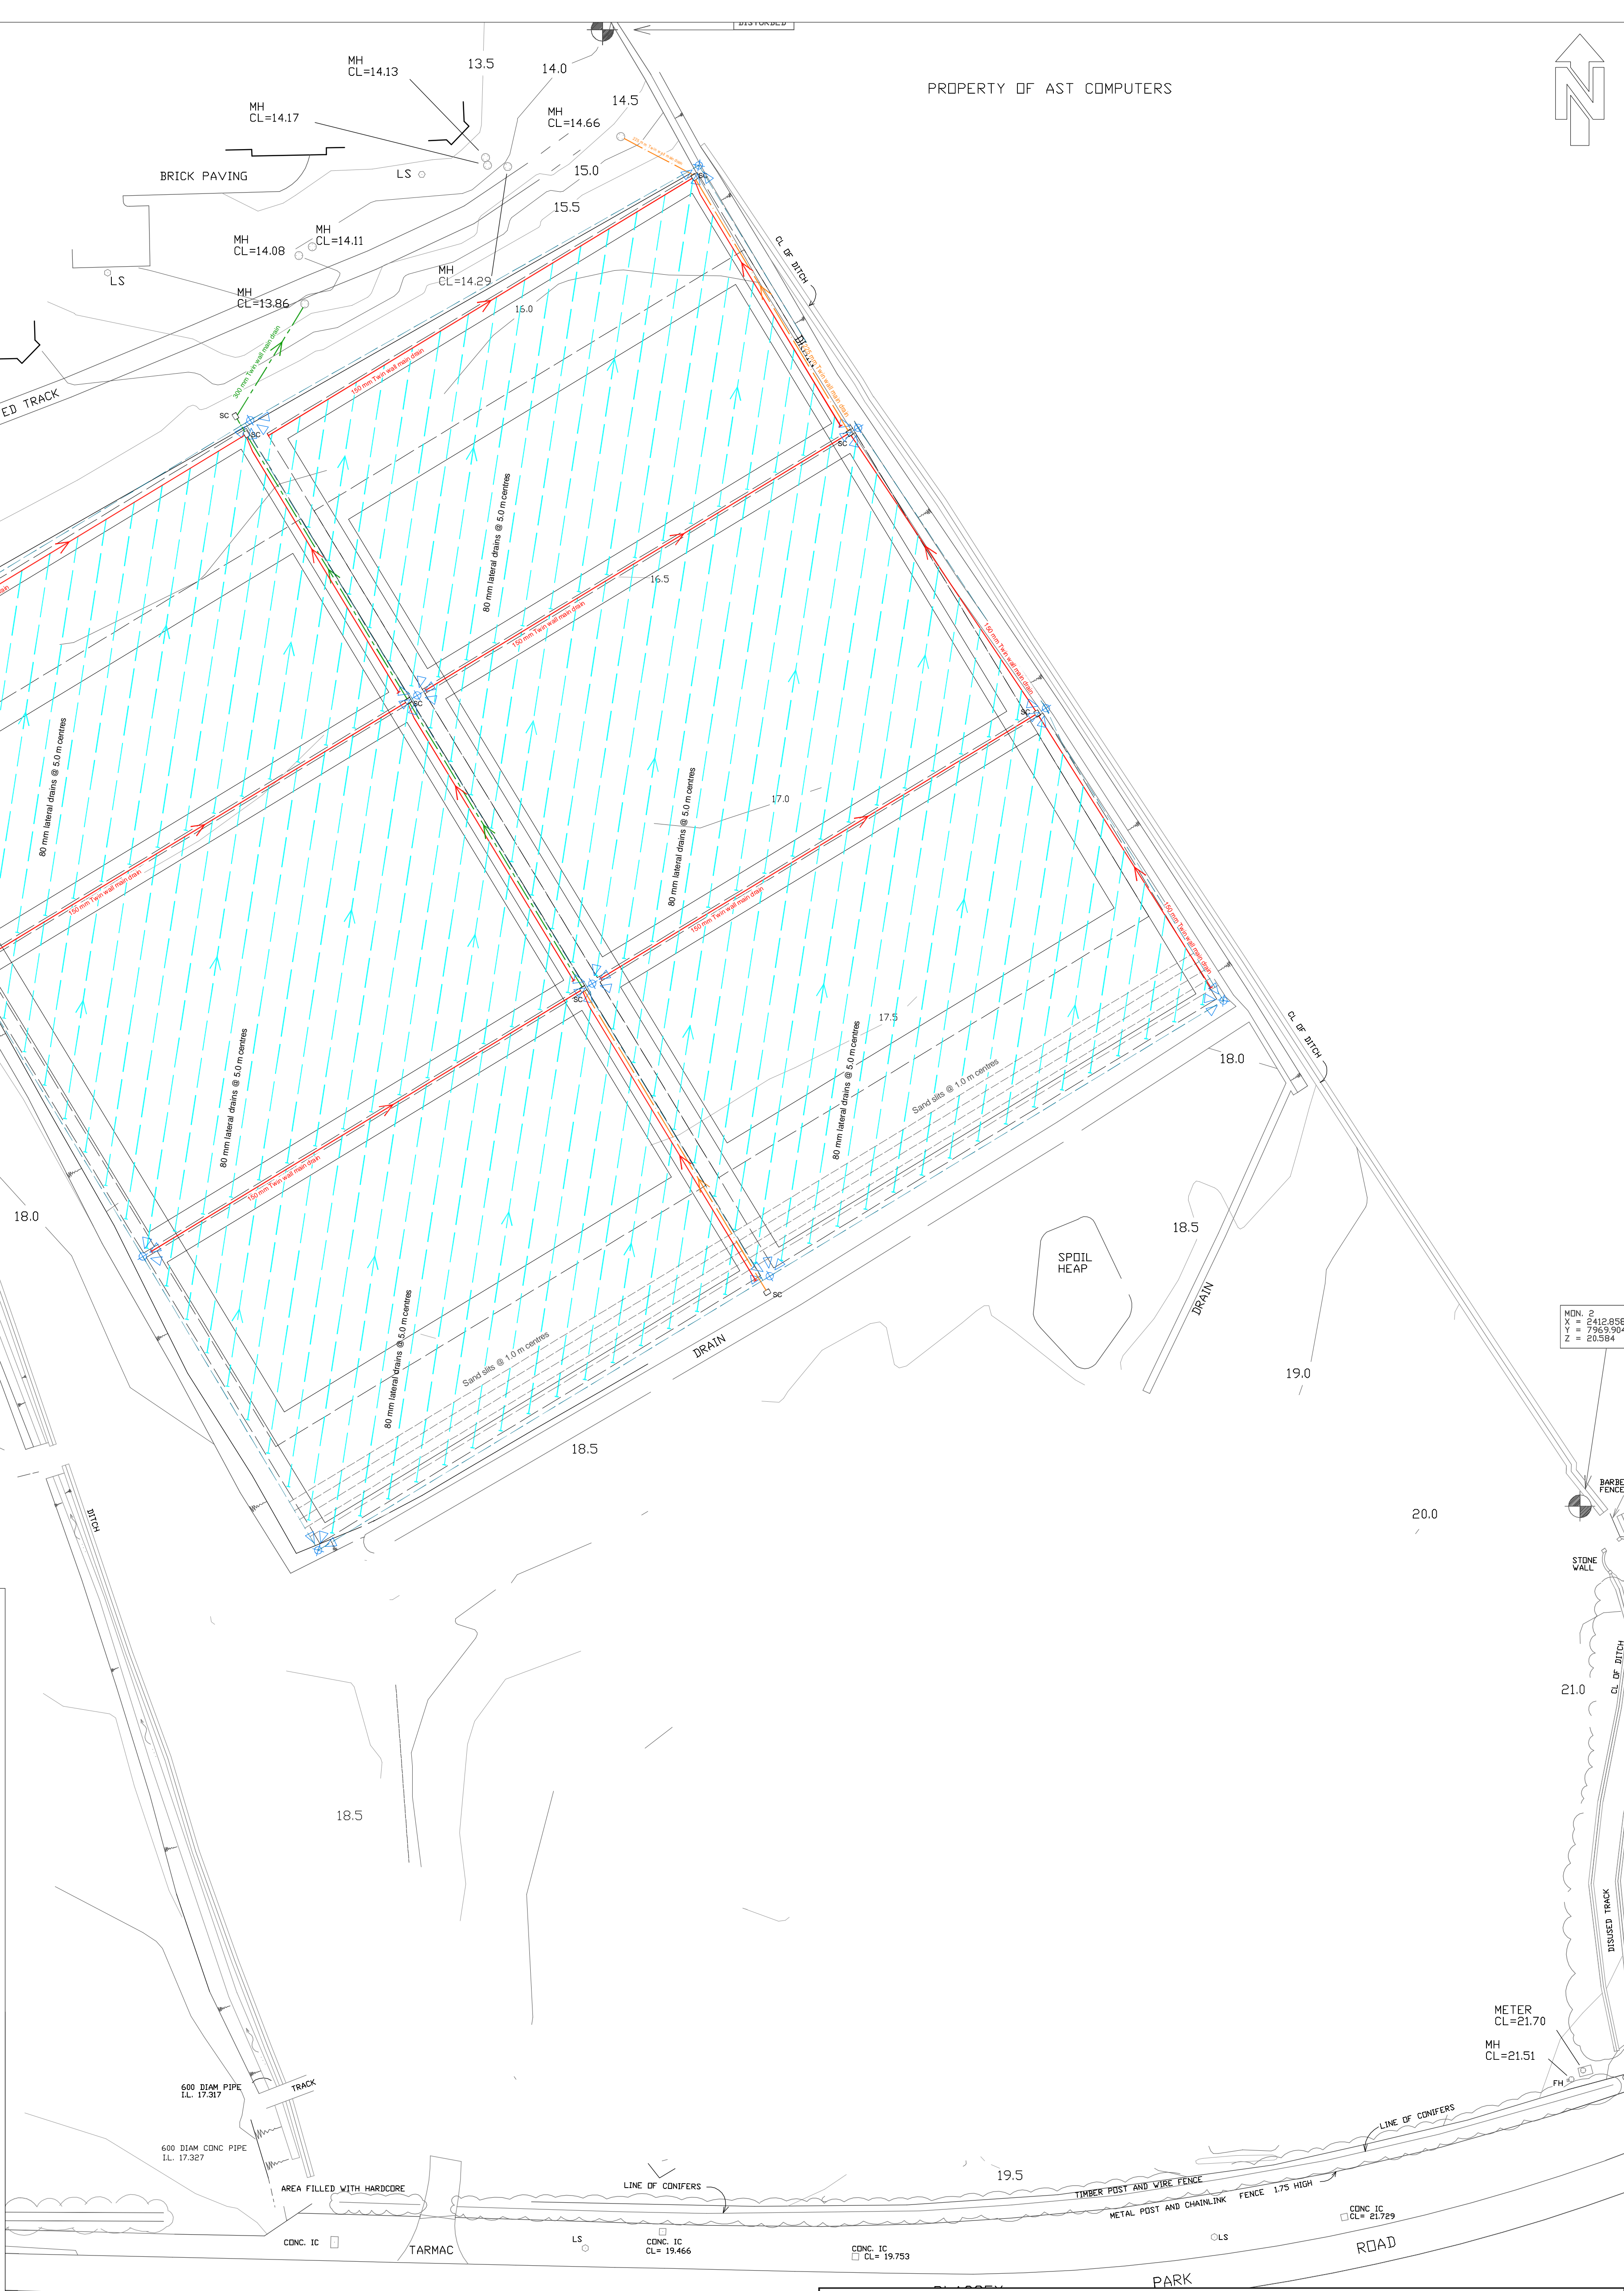

Gravel raft profile with slit drains.

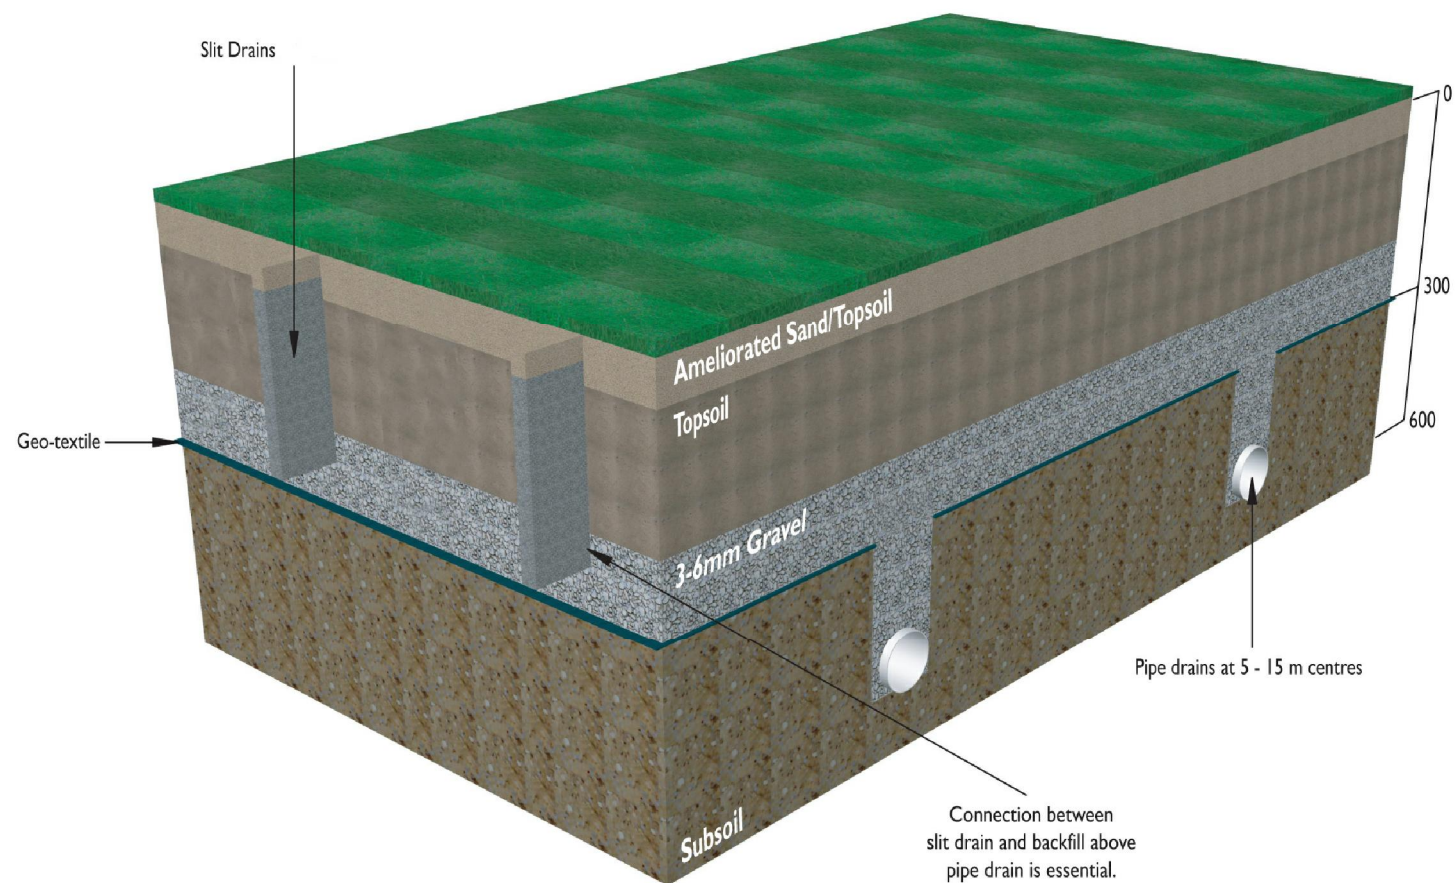

STRI